



A B C D E F G H J K L M N P Q

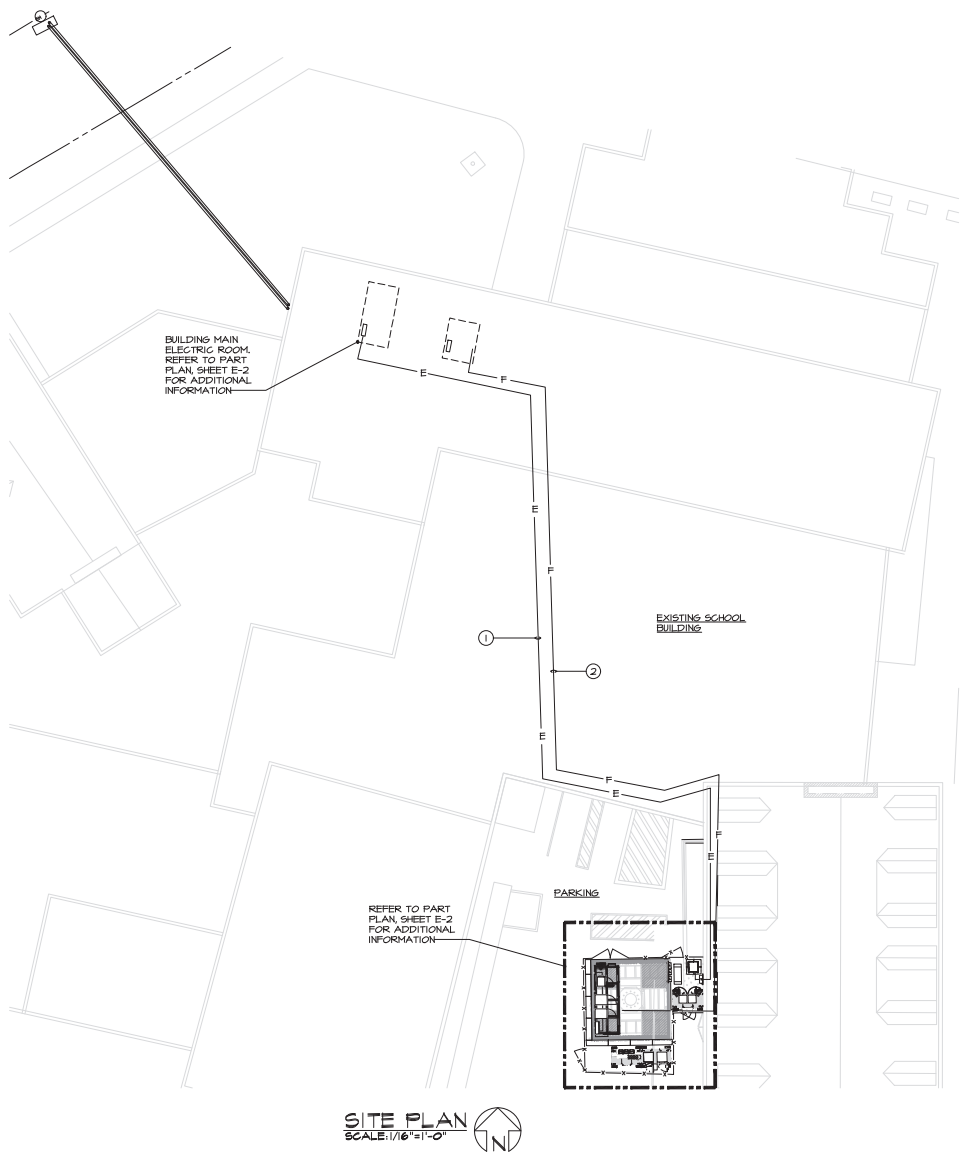

DRAWING NOTES


- ① EXTEND 3/4"Ø1/4" GRD - 2" CONDUIT FROM NEW 3P225A CIRCUIT BREAKER MOUNTED IN EXISTING SWITCHBOARD LOCATED IN BUILDING MAIN ELECTRIC ROOM. EXTEND FEEDER THROUGH DROP CEILING, DOWN HALLWAY AND PUNCH THROUGH EXTERIOR WALL DOWN EXTERIOR WALL AND BE SUPPORTED BY SLEEPERS TO PROPOSED WEATHERPROOF 600 VOLT RATED SAFETY DISCONNECT SWITCH MOUNTED ON UTILITY BACK BOARD. SEAL ALL PENETRATIONS WITH APPROVED WEATHERPROOF SEALANT.
- ② EXTEND TWO (2) - 2" CONDUITS WITH NYLON FILL ROPE FROM PROPOSED TELCO BACK BOARD LOCATED IN SCHOOL TELEPHONE CLOSET #149A AND EXTEND THROUGH DROP CEILING, DOWN HALLWAY AND PUNCH THROUGH EXTERIOR WALL DOWN EXTERIOR WALL AND BE SUPPORTED BY SLEEPERS TO PROPOSED AT&T TEMPORARY (LX2) CABINET. SEAL ALL PENETRATIONS WITH APPROVED WEATHERPROOF SEALANT. COORDINATE FIBER ROUTING WITH AT&T REPRESENTATIVE IN THE FIELD.

 Exhibit 20
OZAH Case No: CU 24-14



SITE ID: SIMD010145
SITE NAME: DUNNAVANT RELO FOR BOYER PLACE (YESHIVA TEMP)
(FA NUMBER: 12573579)
SITE ADDRESS: 2010 LINDEN LANE
ROCKVILLE, MD 20810
MONTGOMERY COUNTY

REVISION BLOCK		
NO.	DESCRIPTION	DATE
2	COUNTY COMMENTS	01/20/2023
1	PERMIT DWG-S	01/13/2023

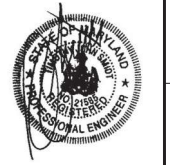

I HEREBY CERTIFY THAT THESE DOCUMENTS WERE PREPARED OR APPROVED BY ME, TIMOTHY JOHN SMITH, AND THAT I AM A DULY LICENSED PROFESSIONAL ENGINEER UNDER THE LAWS OF THE STATE OF MARYLAND. LICENSE NO. 21809, EXPIRATION DATE: MAY 08, 2025.

DRAWN BY: BLN
DESIGNED BY: BLN/TJS
ORIGINAL DATE: 06/16/2023
TEI PROJECT#: 23014L
DESIGN SCALE: AS NOTED



SHEET TITLE
Site Plan and Notes

SHEET NUMBER
E-1