
 
 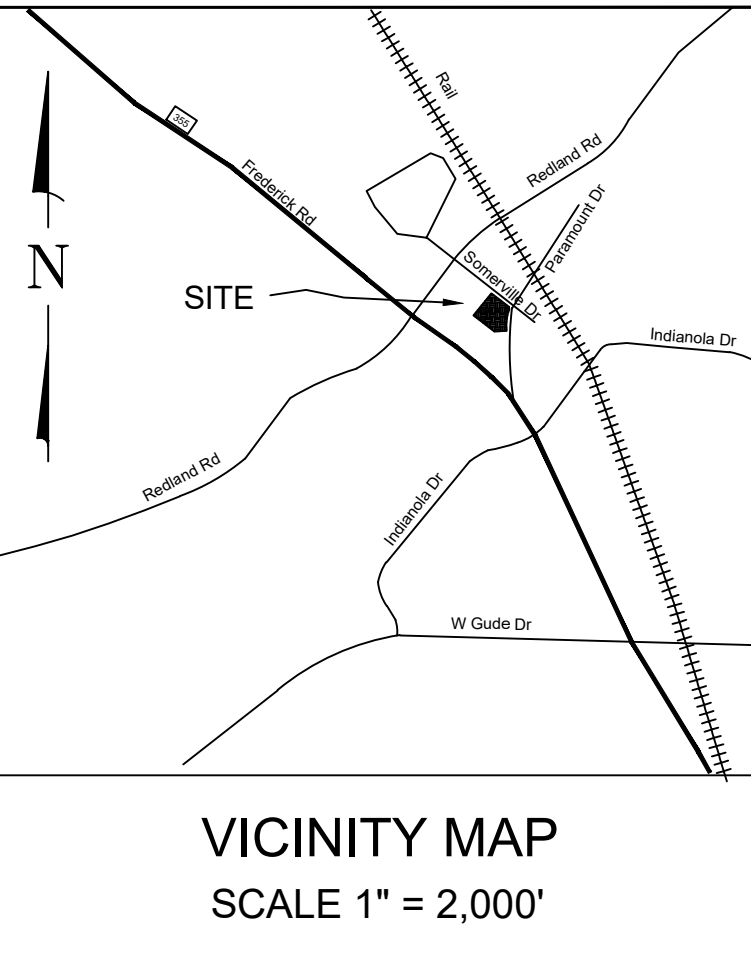
 
 
 
 
 
 




Professional Certification
I hereby certify that these documents were prepared and
approved by me, and that I am a duly licensed
Professional Engineer under the Laws of the State of
Maryland. Lic. No. 16905 Exp. Date. 04.21.2026

PARAMOUNT SELF STORAGE, LLC
C/O ARCLAND PROPERTY
COMPANY, LLC
1055 THOMAS JEFFERSON ST NW
STE 250
WASHINGTON, D.C. 20007



EXISTING	LEGEND	PROPOSED
	WATER LINE	
	FIRE HYDRANT	
	SEWER LINE	
	STORM DRAIN LINE	
	OVERHEAD UTILITY WIRES	
	GAS LINE	
	UNDERGROUND ELECTRIC	
	COMCAST CONDUIT	
	VERIZON CONDUIT	
	UTILITY EASEMENT	

[illegible]

TAX MAP GS22 WSSC 221NW0

PARCEL N421
L.67249, F. 486
4TH ELECTION DISTRICT
MONTGOMERY COUNTY
MARYLAND

PARAMOUNT SELF STORAGE

**DERWOOD, SOMMERVILLE
ADDITION - PARCEL H-2**

PROJ MGR DCA

DRAWN BY DCA

SCALE 1" = 20'

DATE 01.21.2024

**LOCAL MAP AMENDMENT
H157**

CONCEPT UTILITY PLAN

PROJECT NO. 2023.210.12

SHEET NO. _____ OF _____